


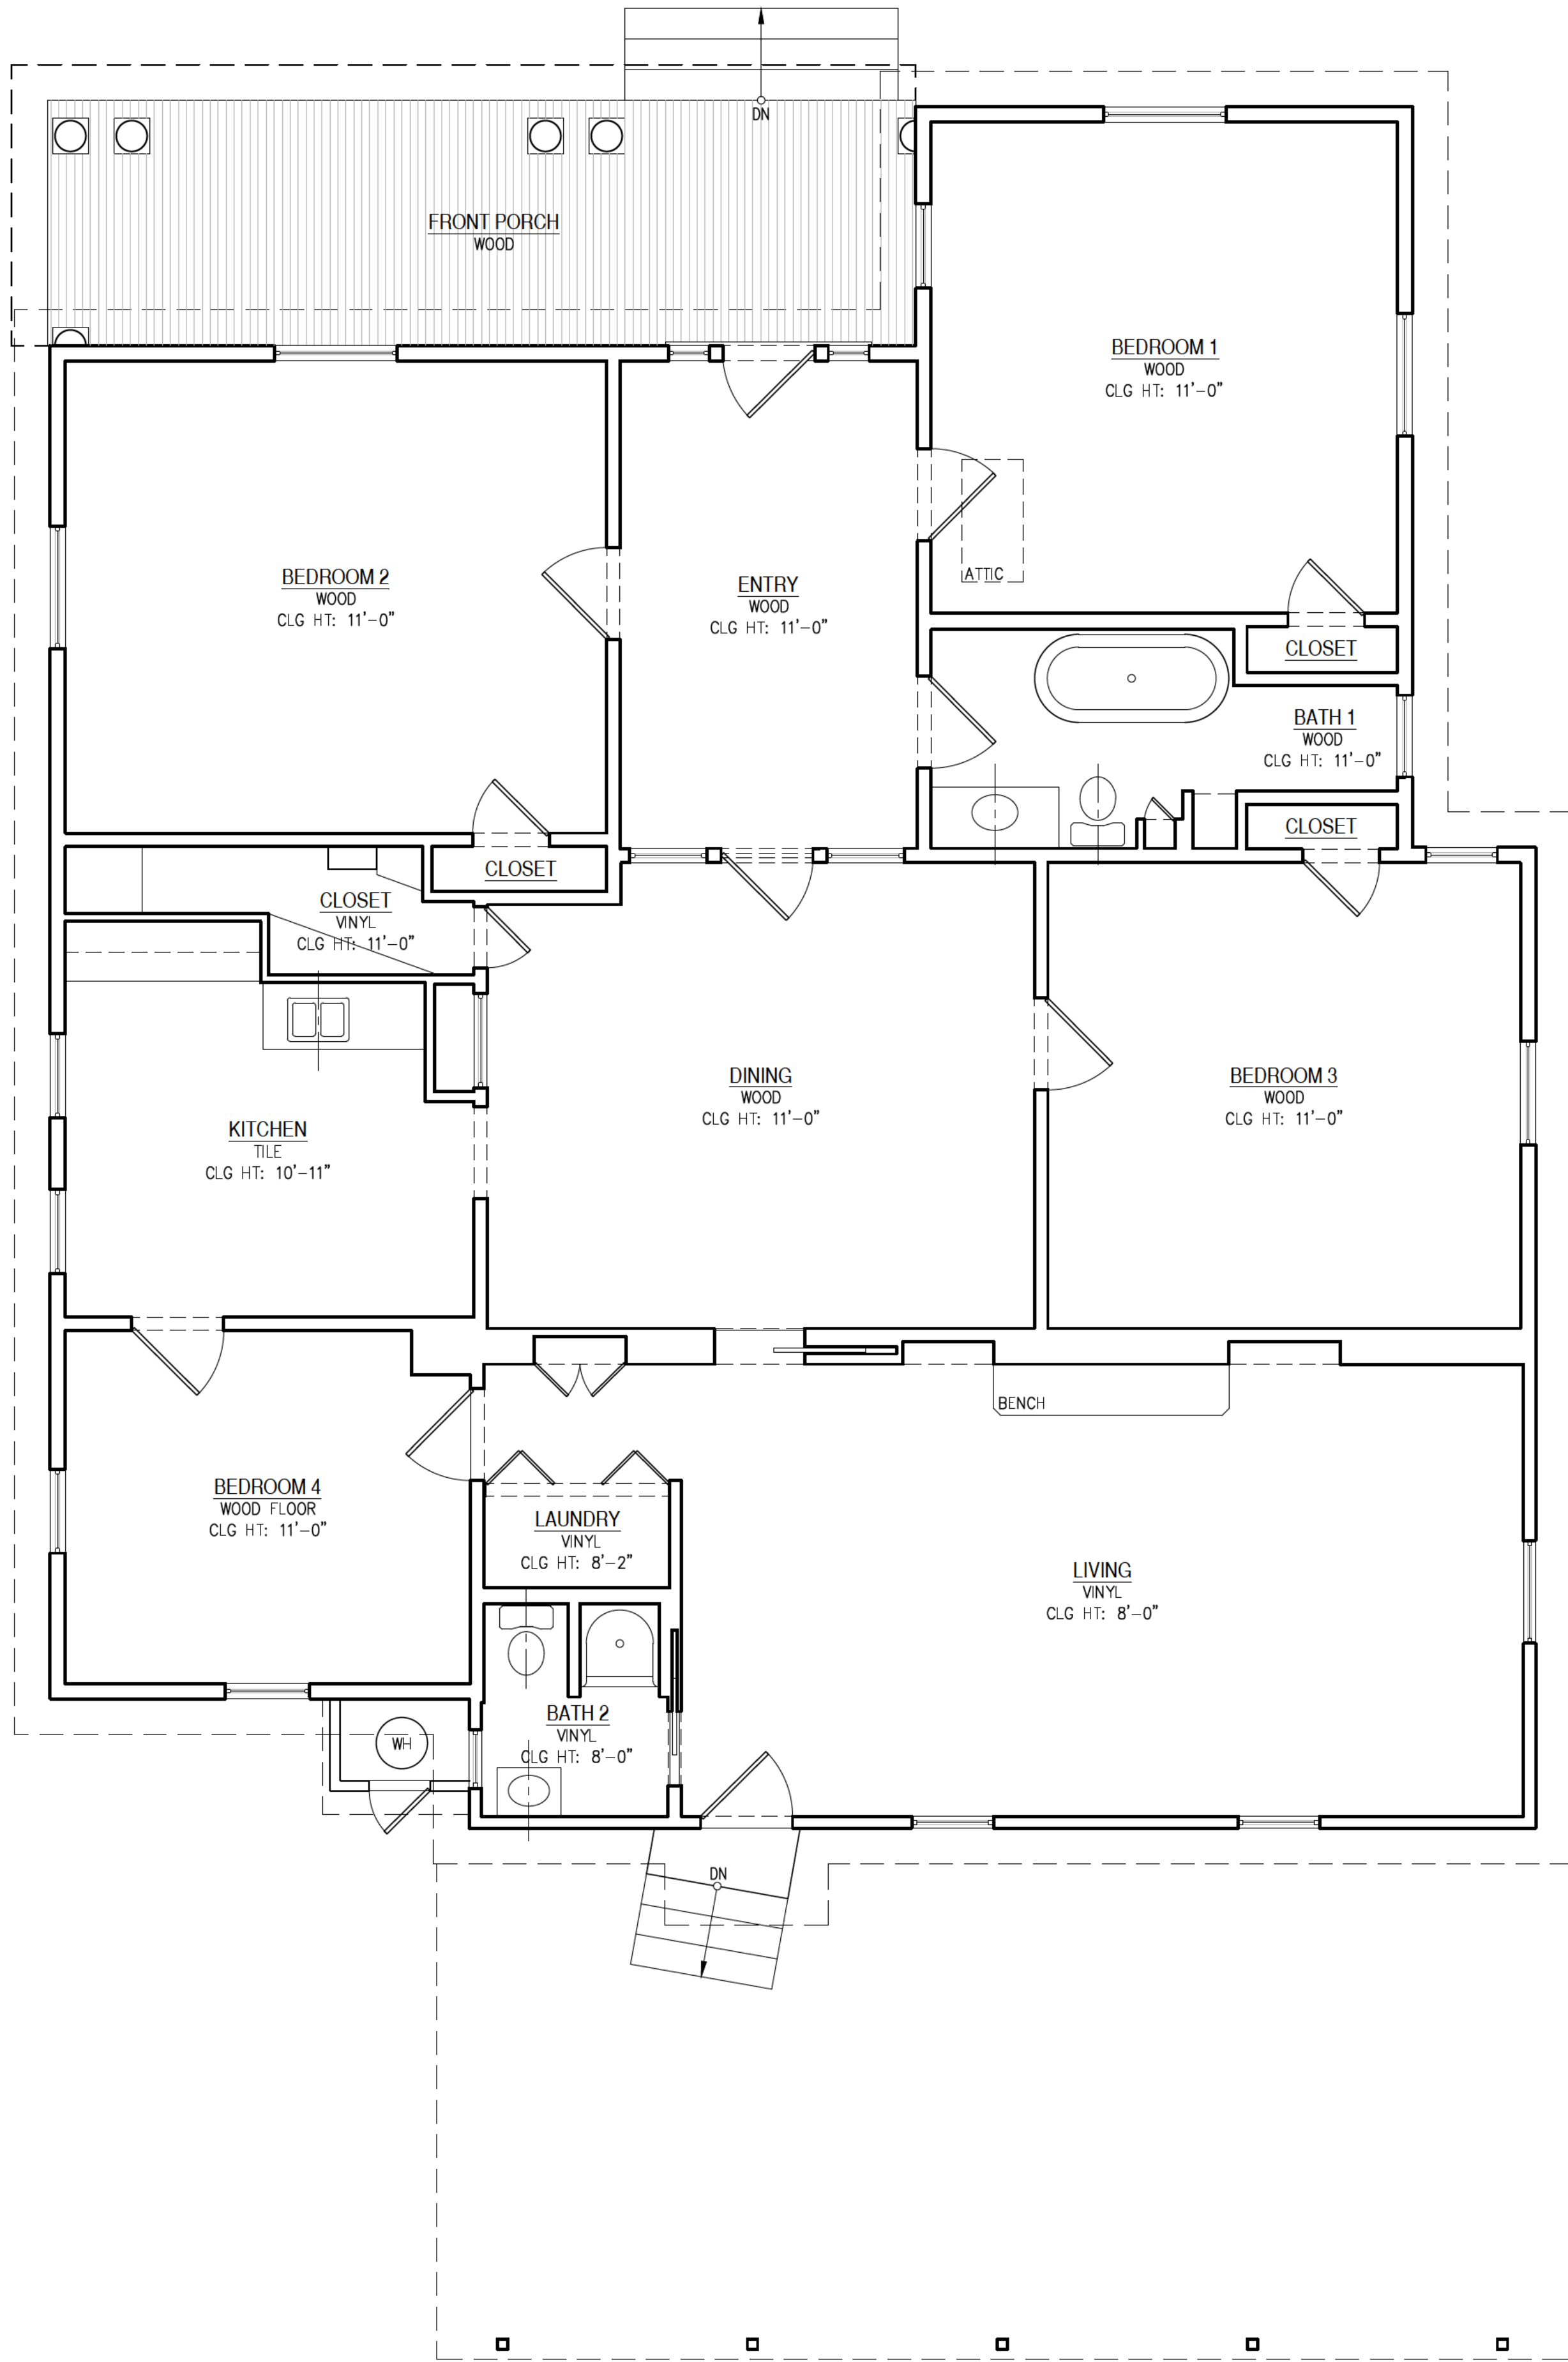

1 FLOOR PLAN: EXTG CONDITIONS
SCALE: 1/4" = 1'-0"





DATE	ISSUED FOR

Tel: 210.883.5529
Fax: 210.320.8209
Email: info@designcoapea.com
PO BOX 90946
San Antonio, TX 78209

SAN ANTONIO, TEXAS

DRAWN:DC
CHECKED:BCF
APPROVED:
DATE: OCTOBER 2, 2020
SHEET NO. EXTG FLOOR PLAN

A1.0

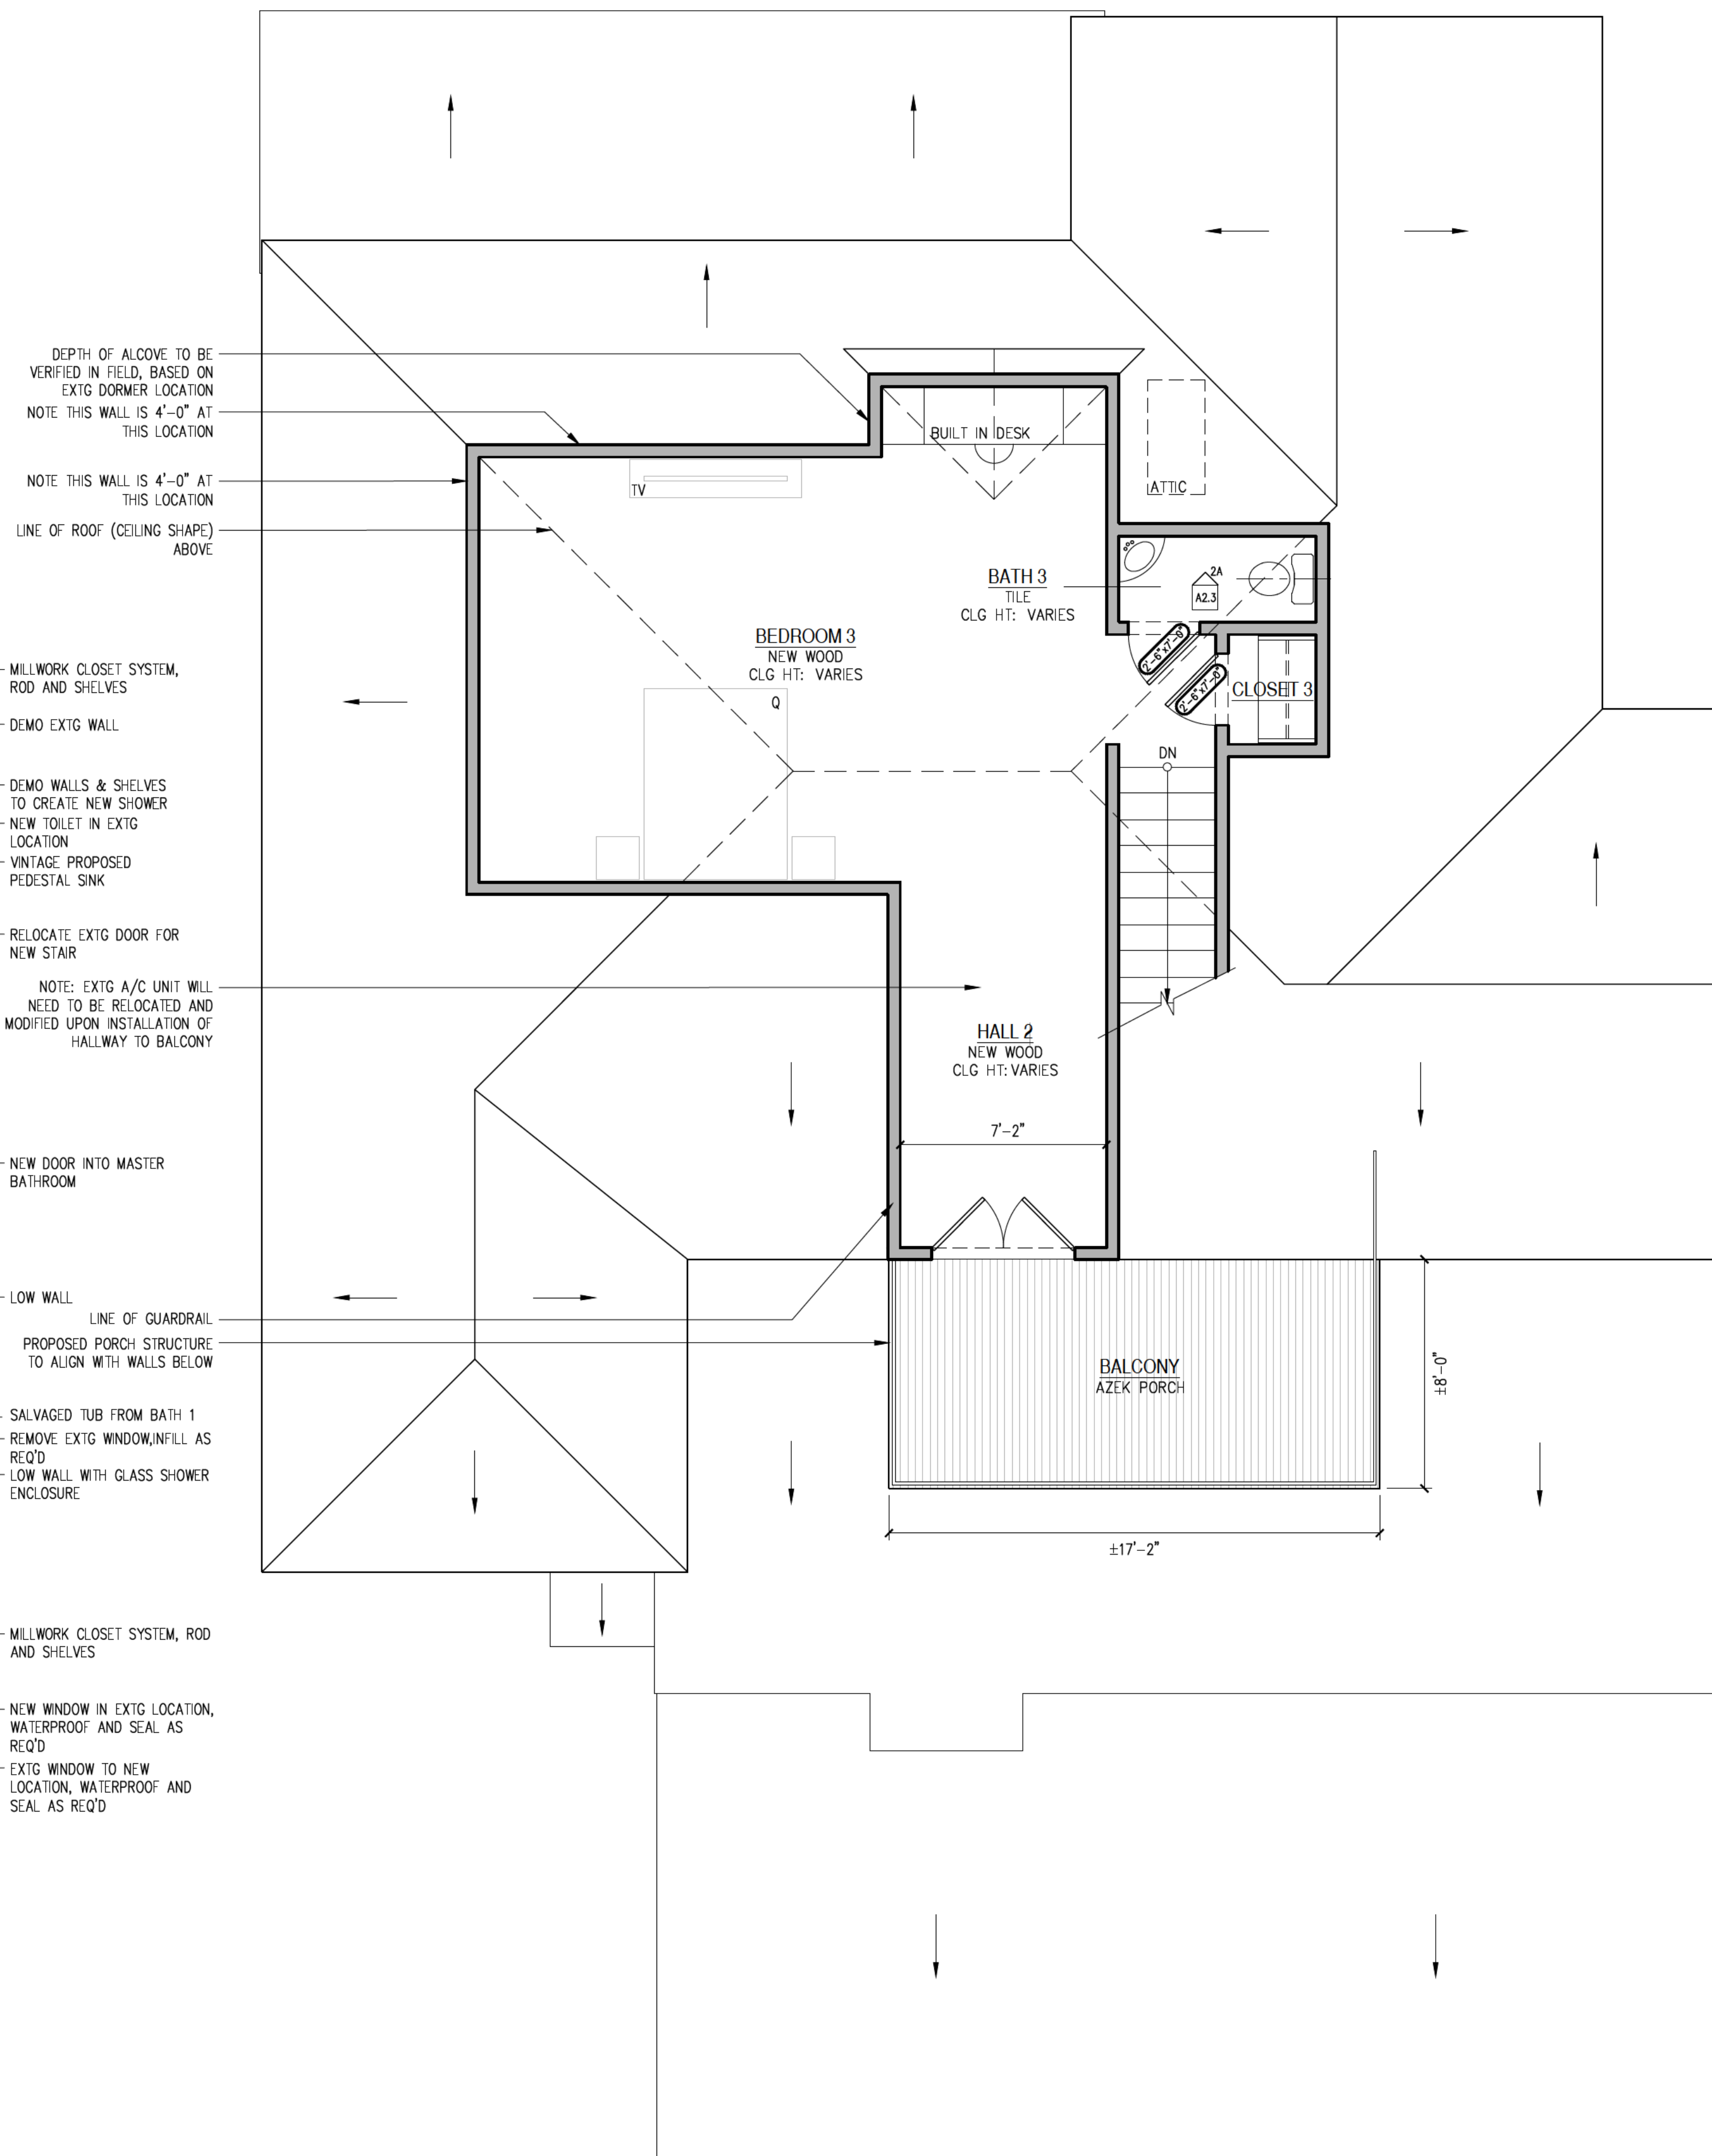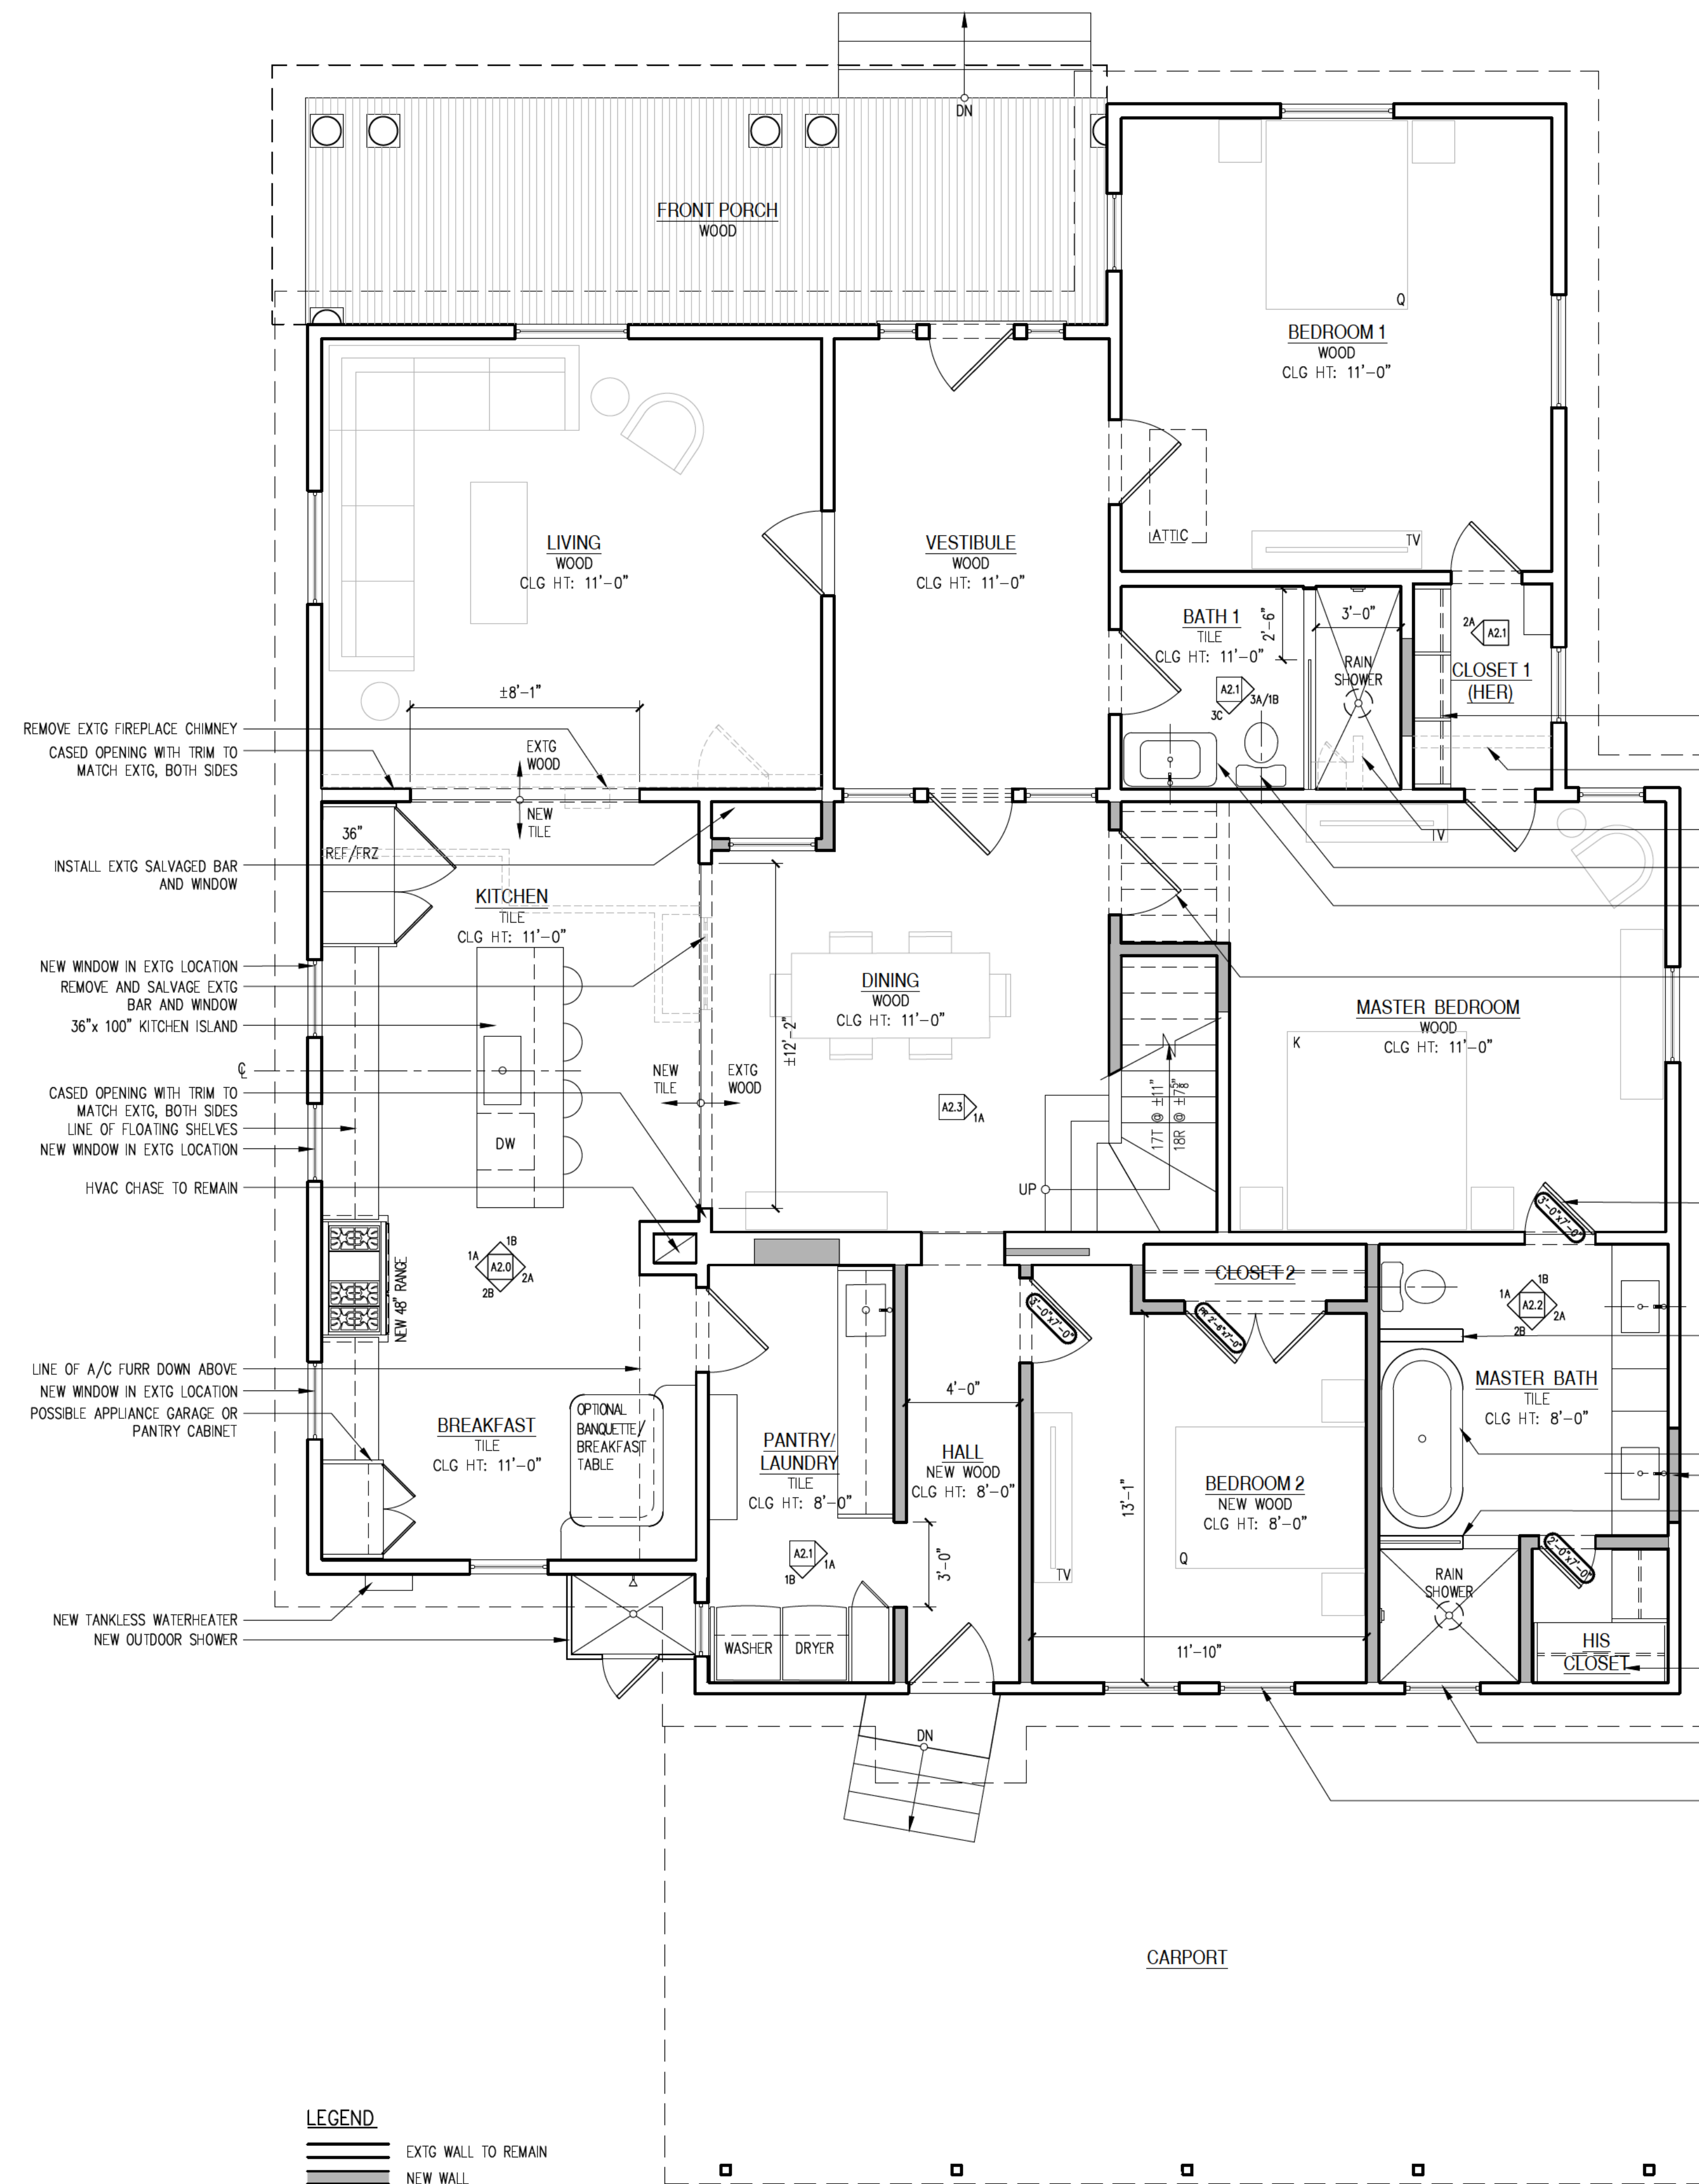


DATE	ISSUED FOR

Fax: 210.320.8249
Email: info@designcoopsa.com
PO BOX 90946
San Antonio, TX 78209



SAN ANTONIO, TEXAS

DRAWN:DC
CHECKED:BCF
APPROVED:
DATE: OCTOBER 2, 2020
SHEET NO. PROPOSED FLOOR PLAN


A1.1

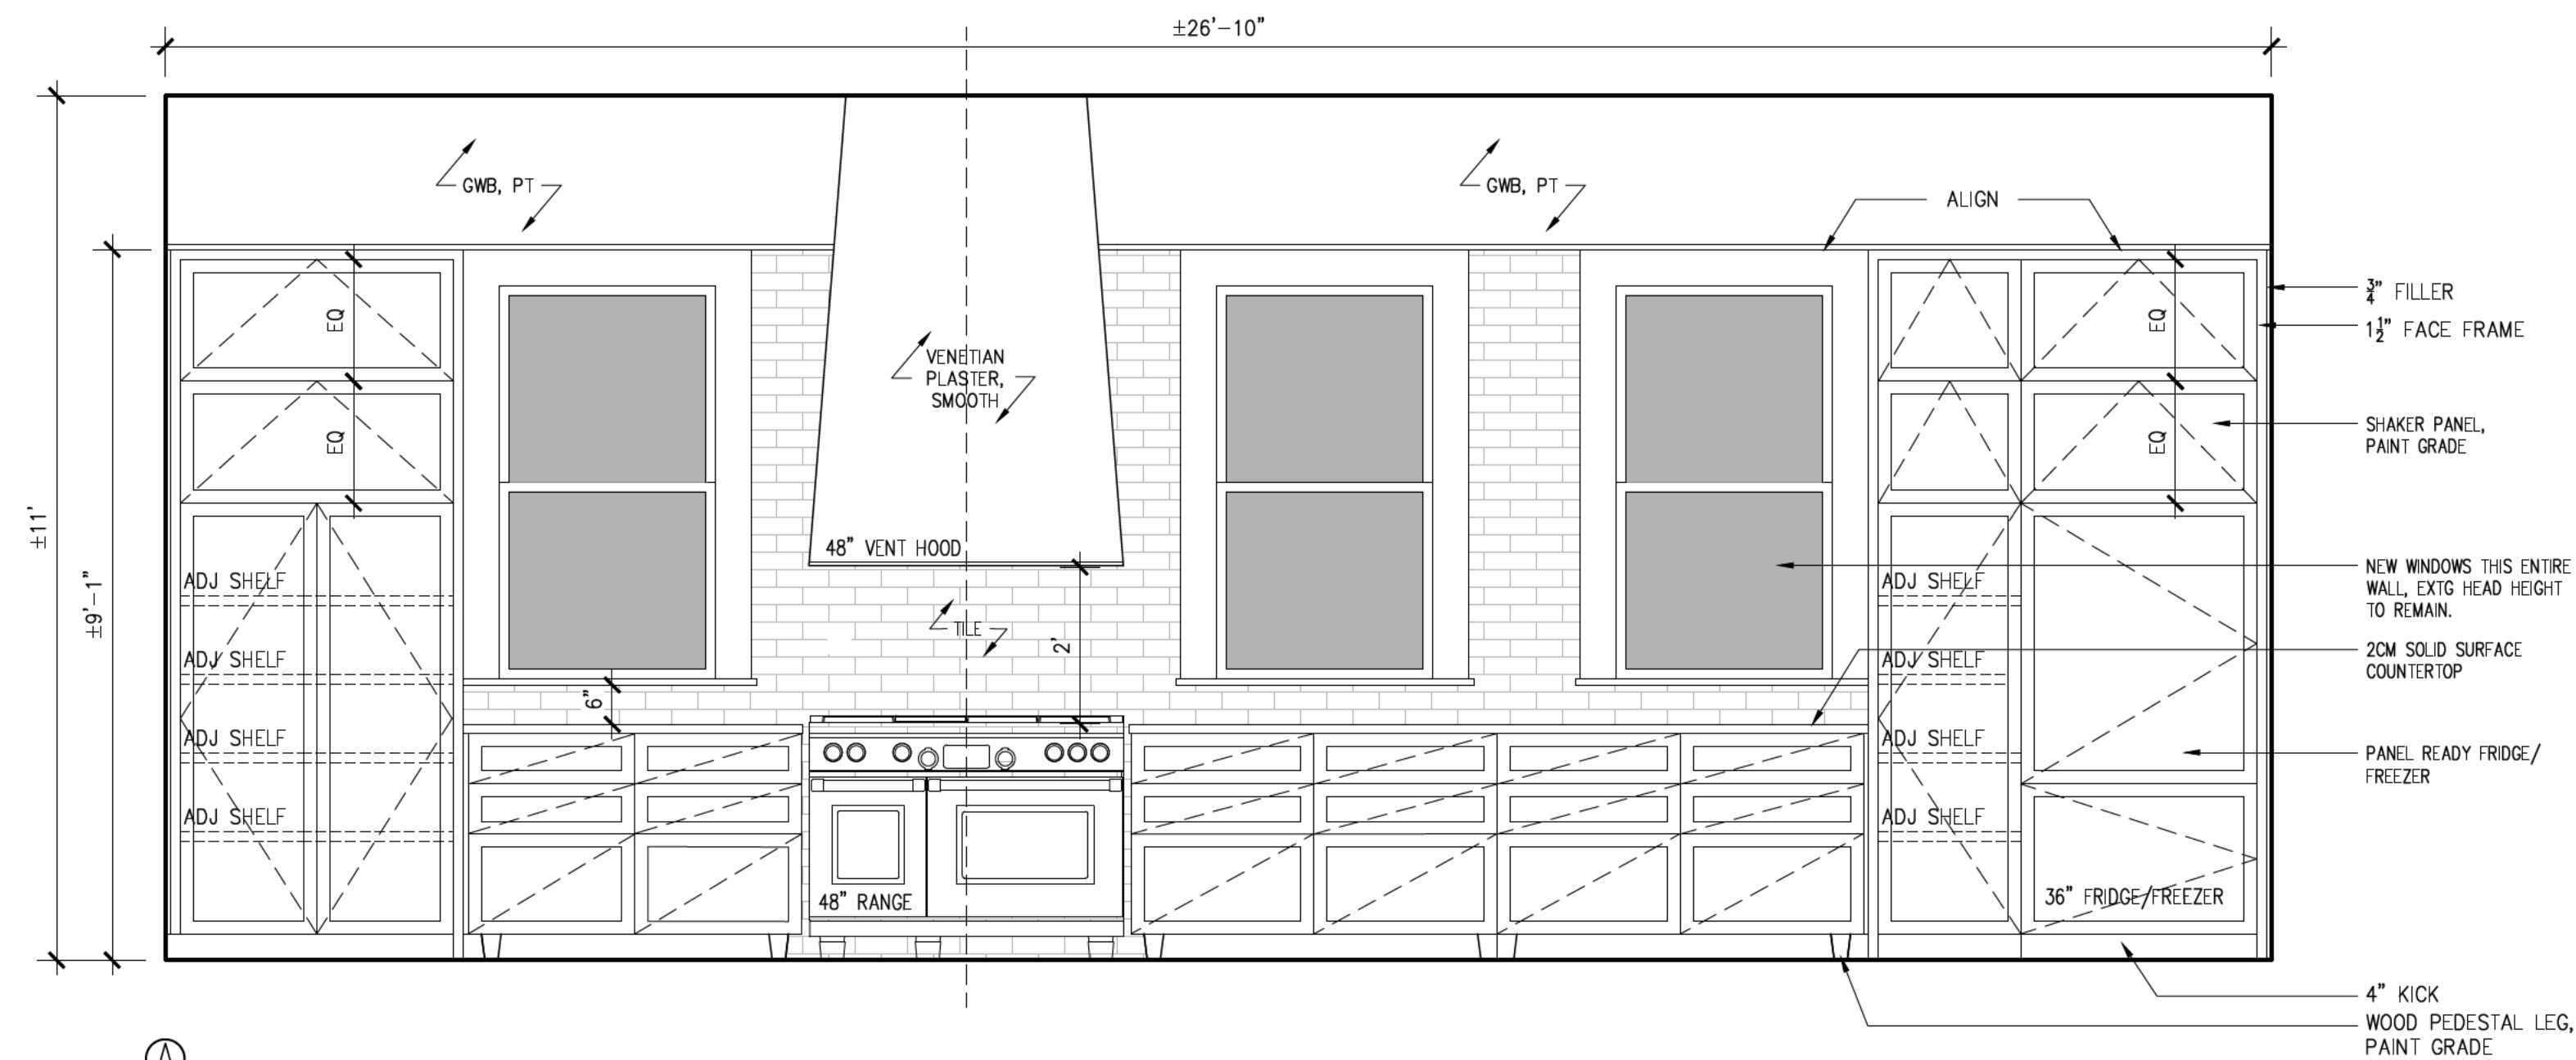

1 INTERIOR ELEVATION: KITCHEN
SCALE: 1/2" = 1'-0"

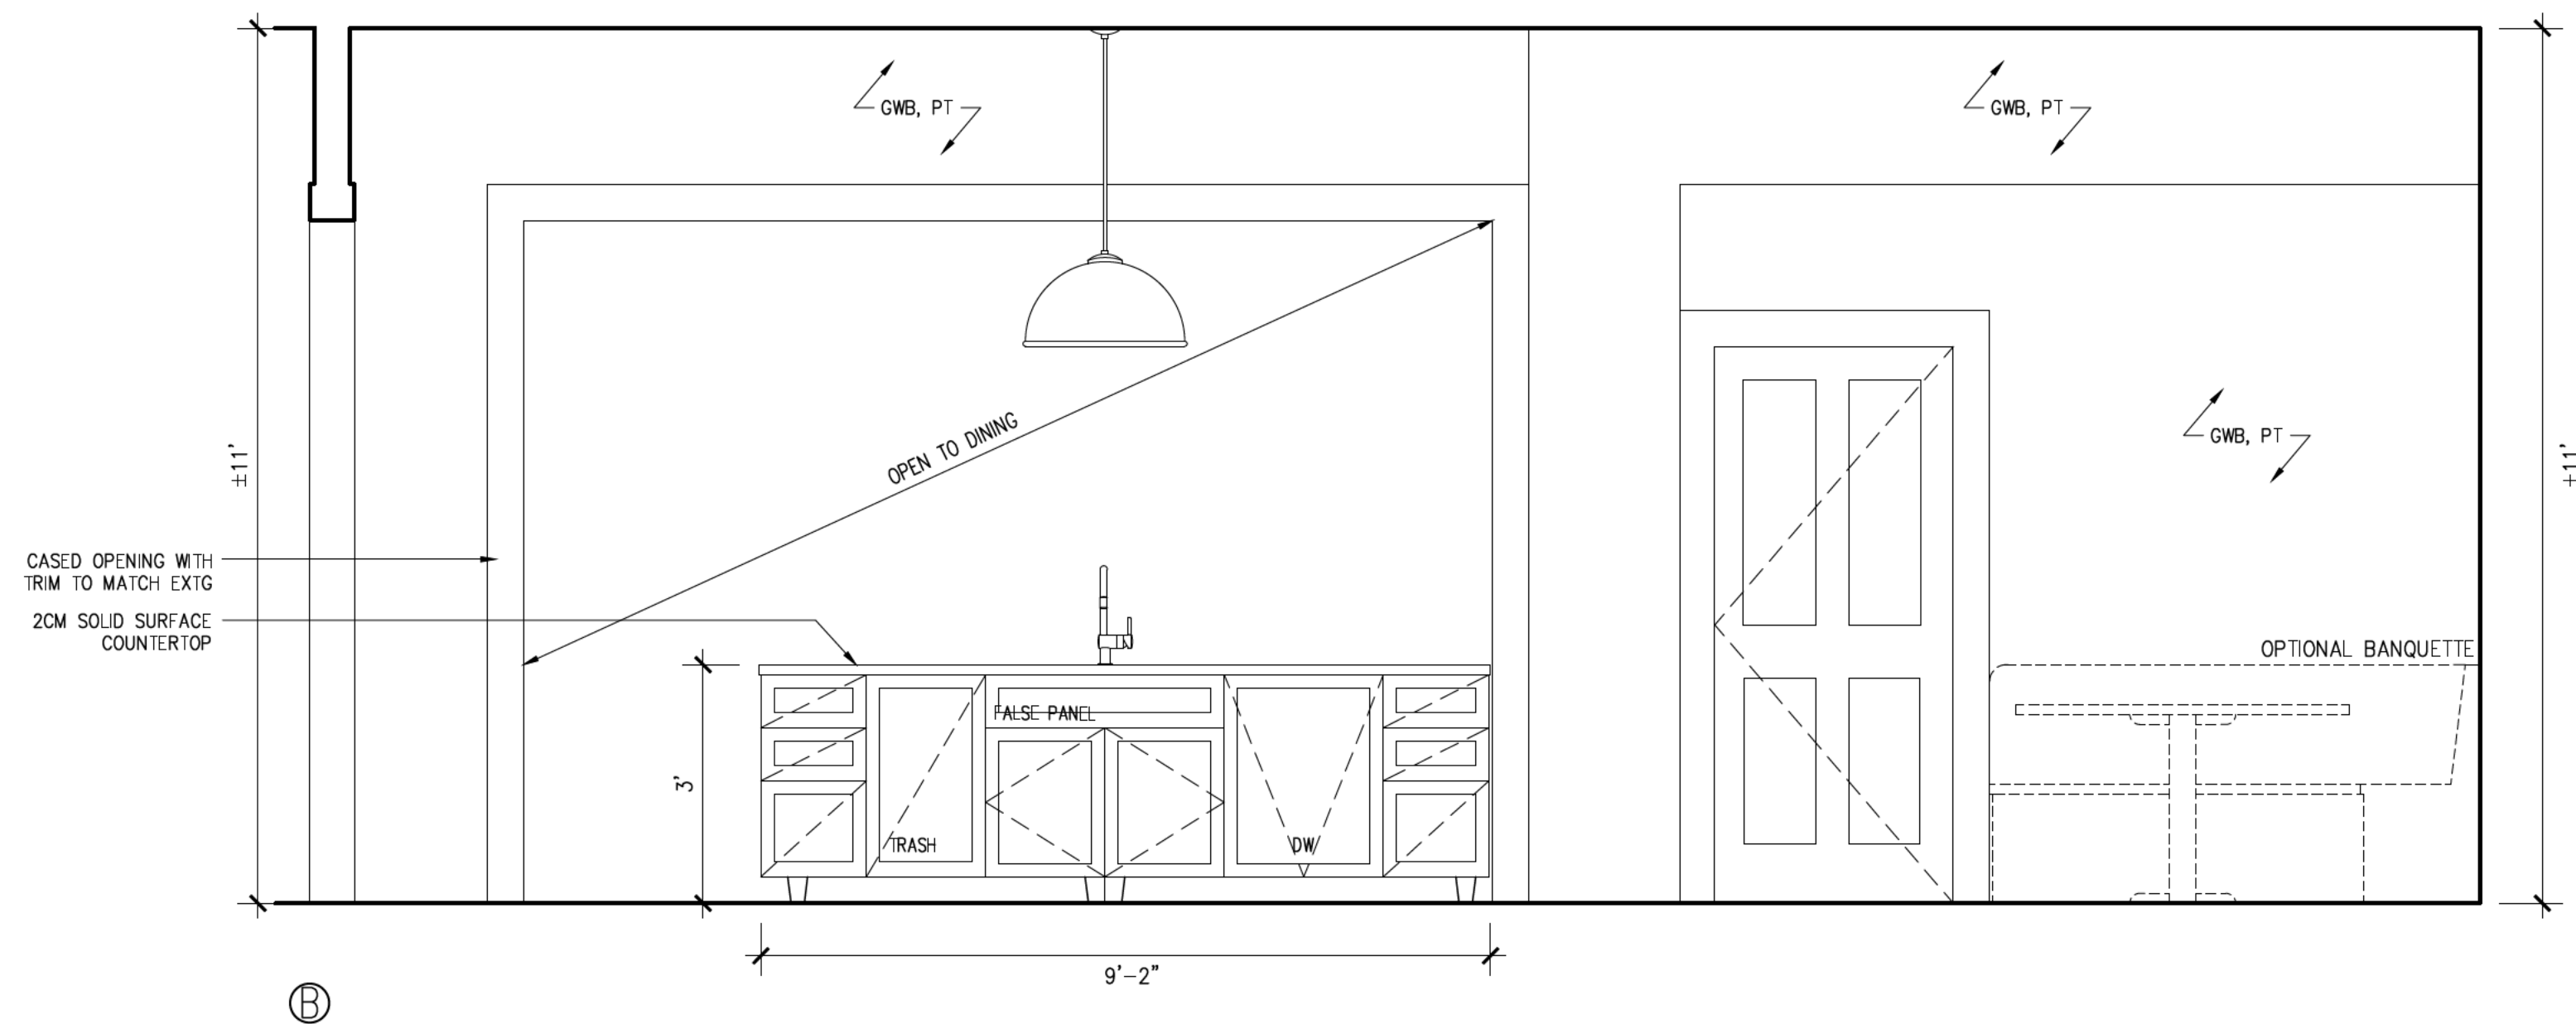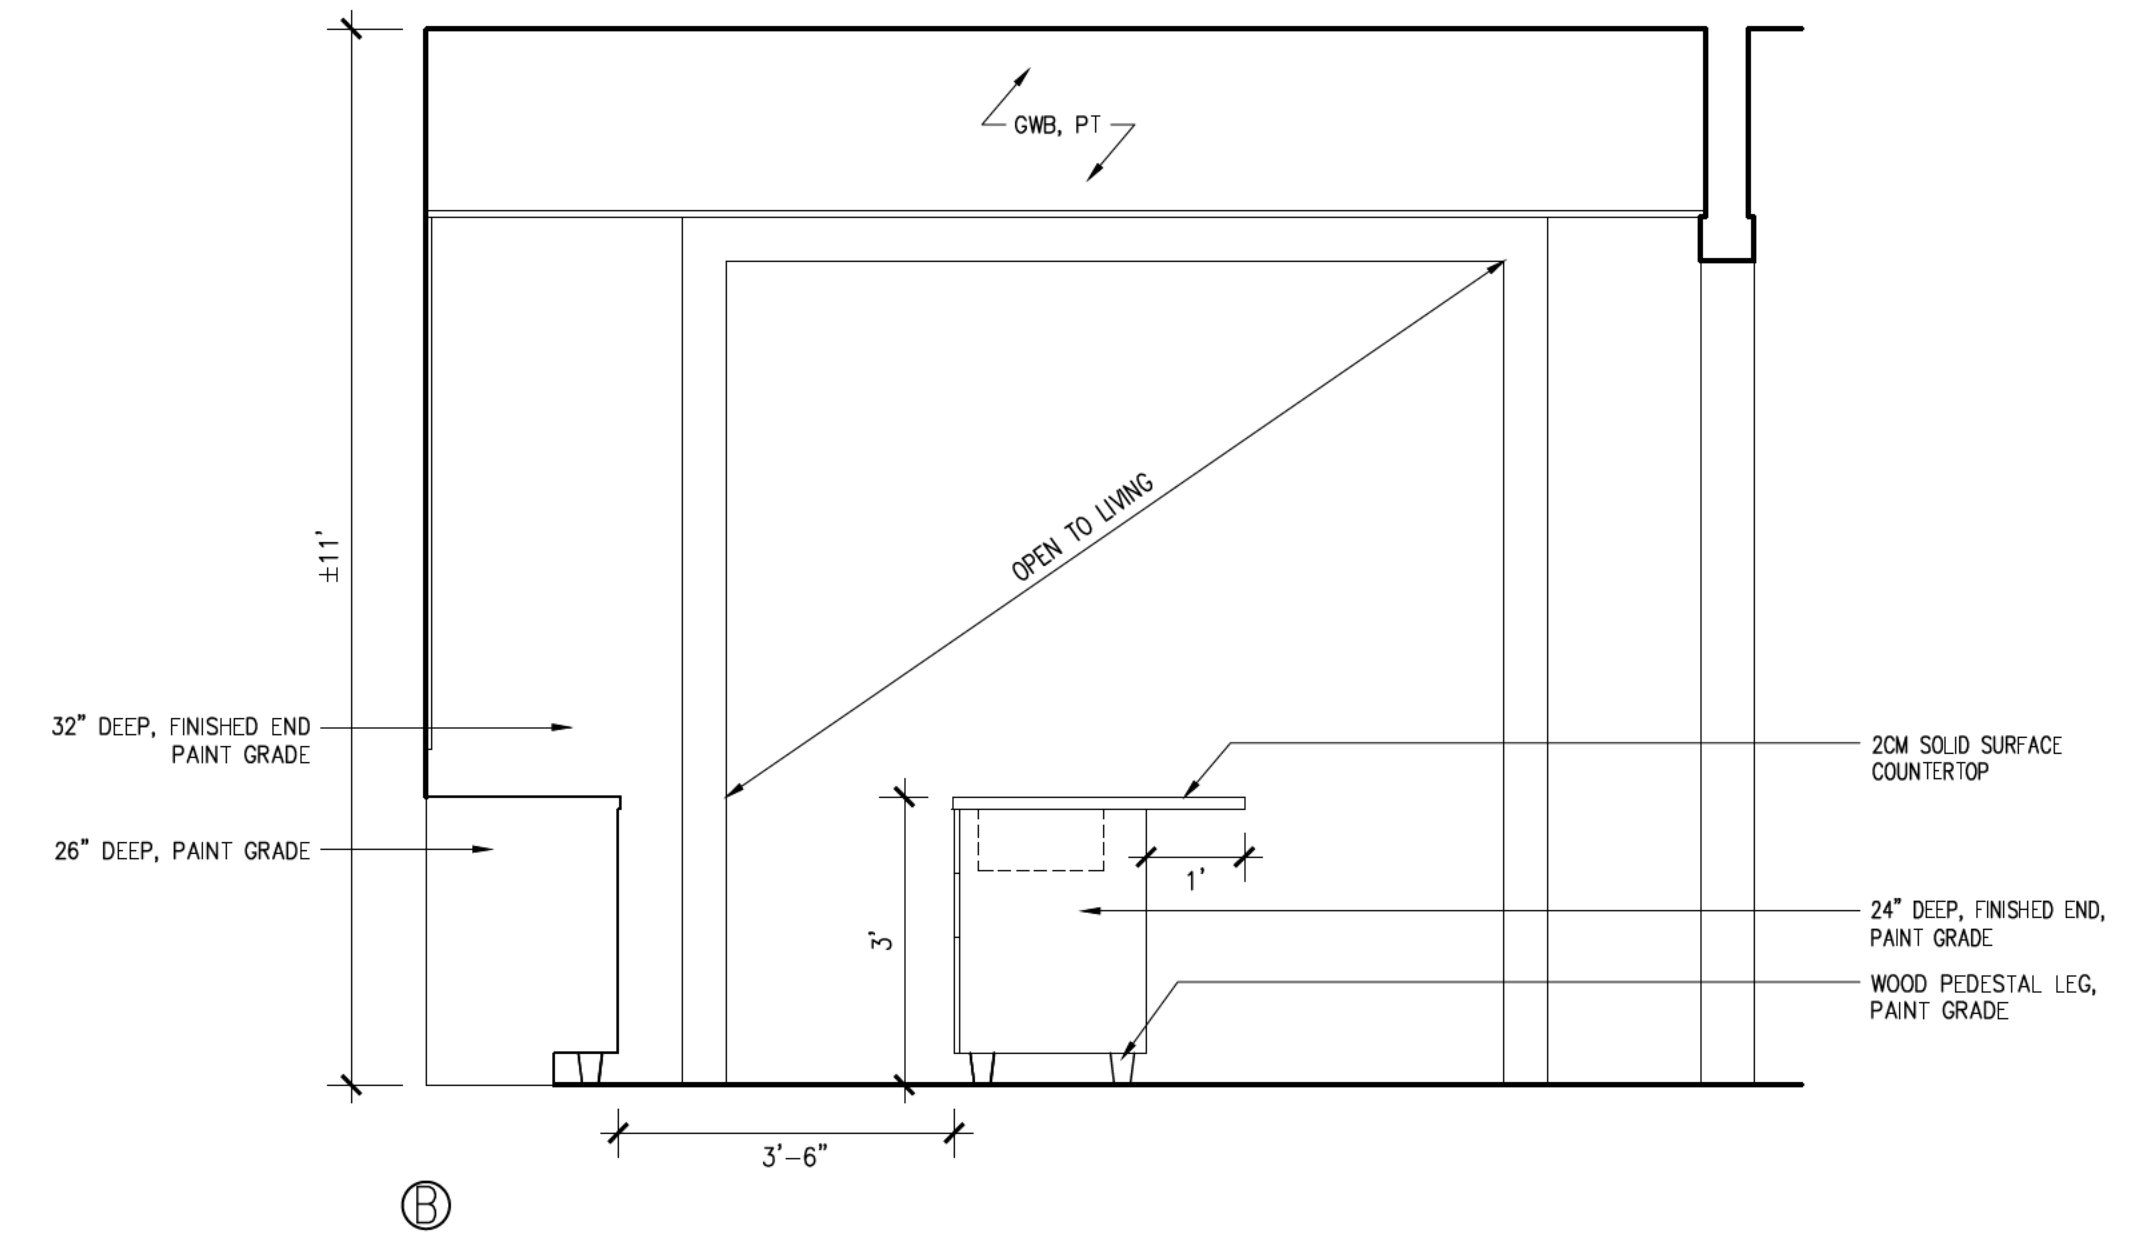

2 INTERIOR ELEVATION: KITCHEN
SCALE: 1/2" = 1'-0"

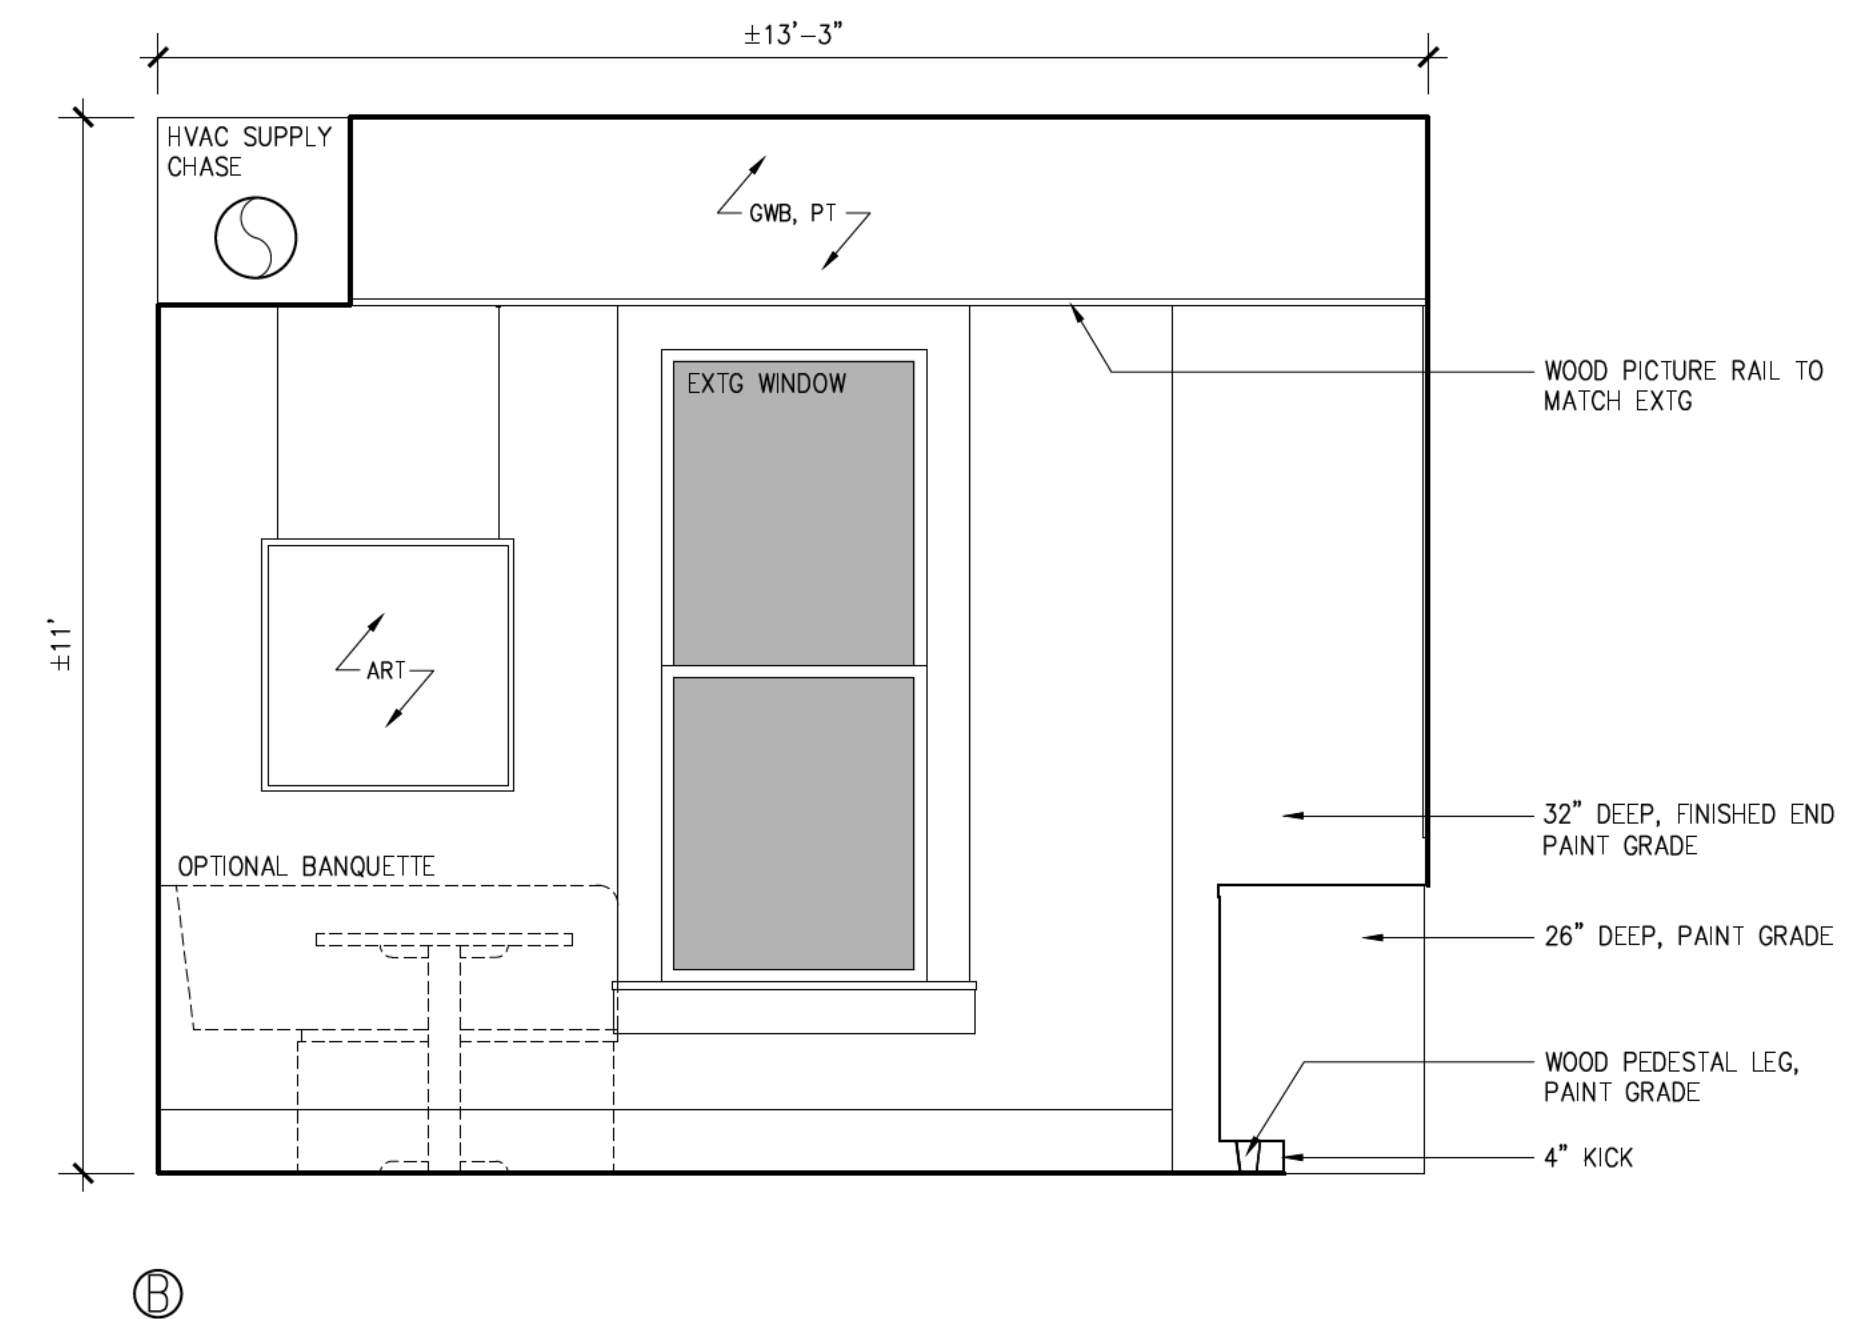



DATE	ISSUED FOR

Tel: 210.883.5529
Fax: 210.320.8209
Email: info@designcoopae.com
PO BOX 90946
San Antonio, TX 78209

SAN ANTONIO, TEXAS

DRAWN:DC
CHECKED:BCF
APPROVED:
DATE: OCTOBER 2, 2020
SHEET NO.
INTERIOR ELEVATIONS

A2.0

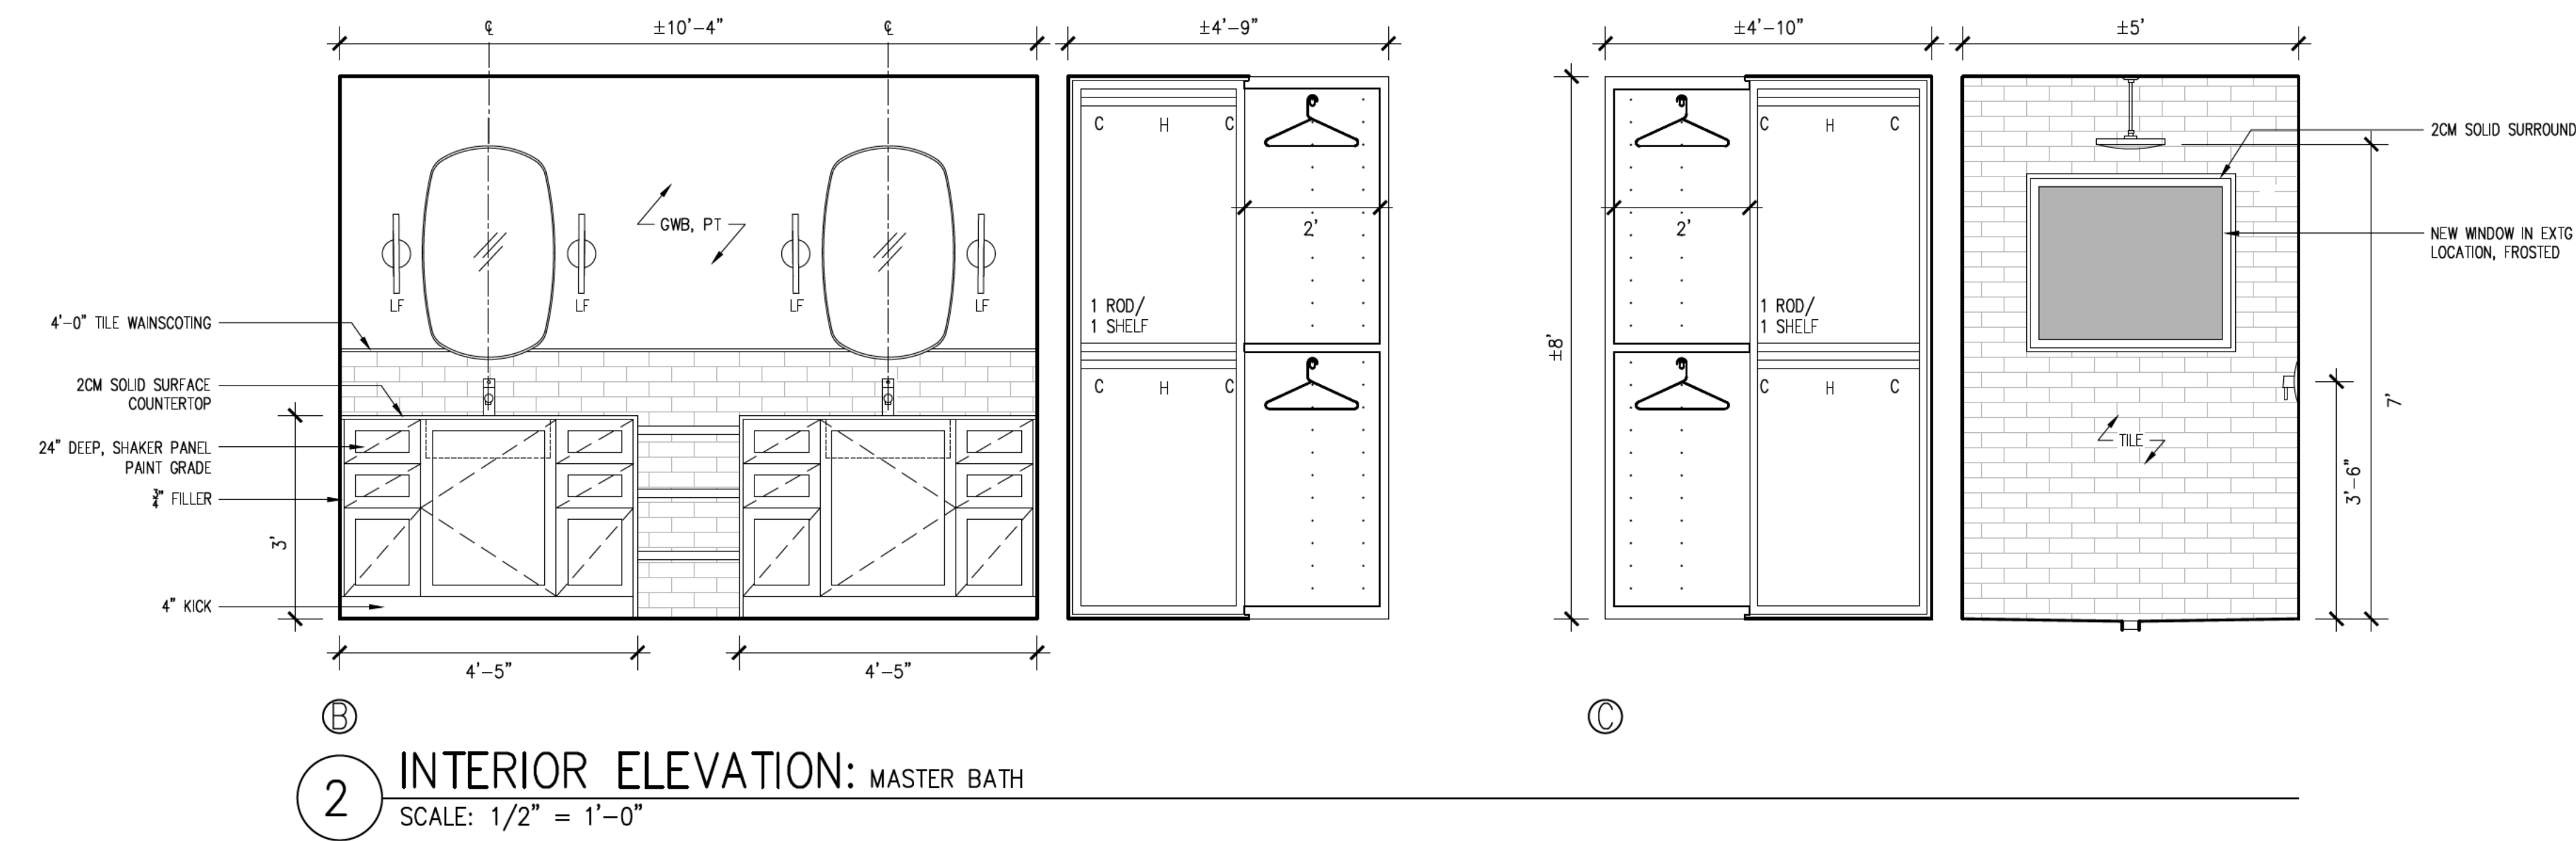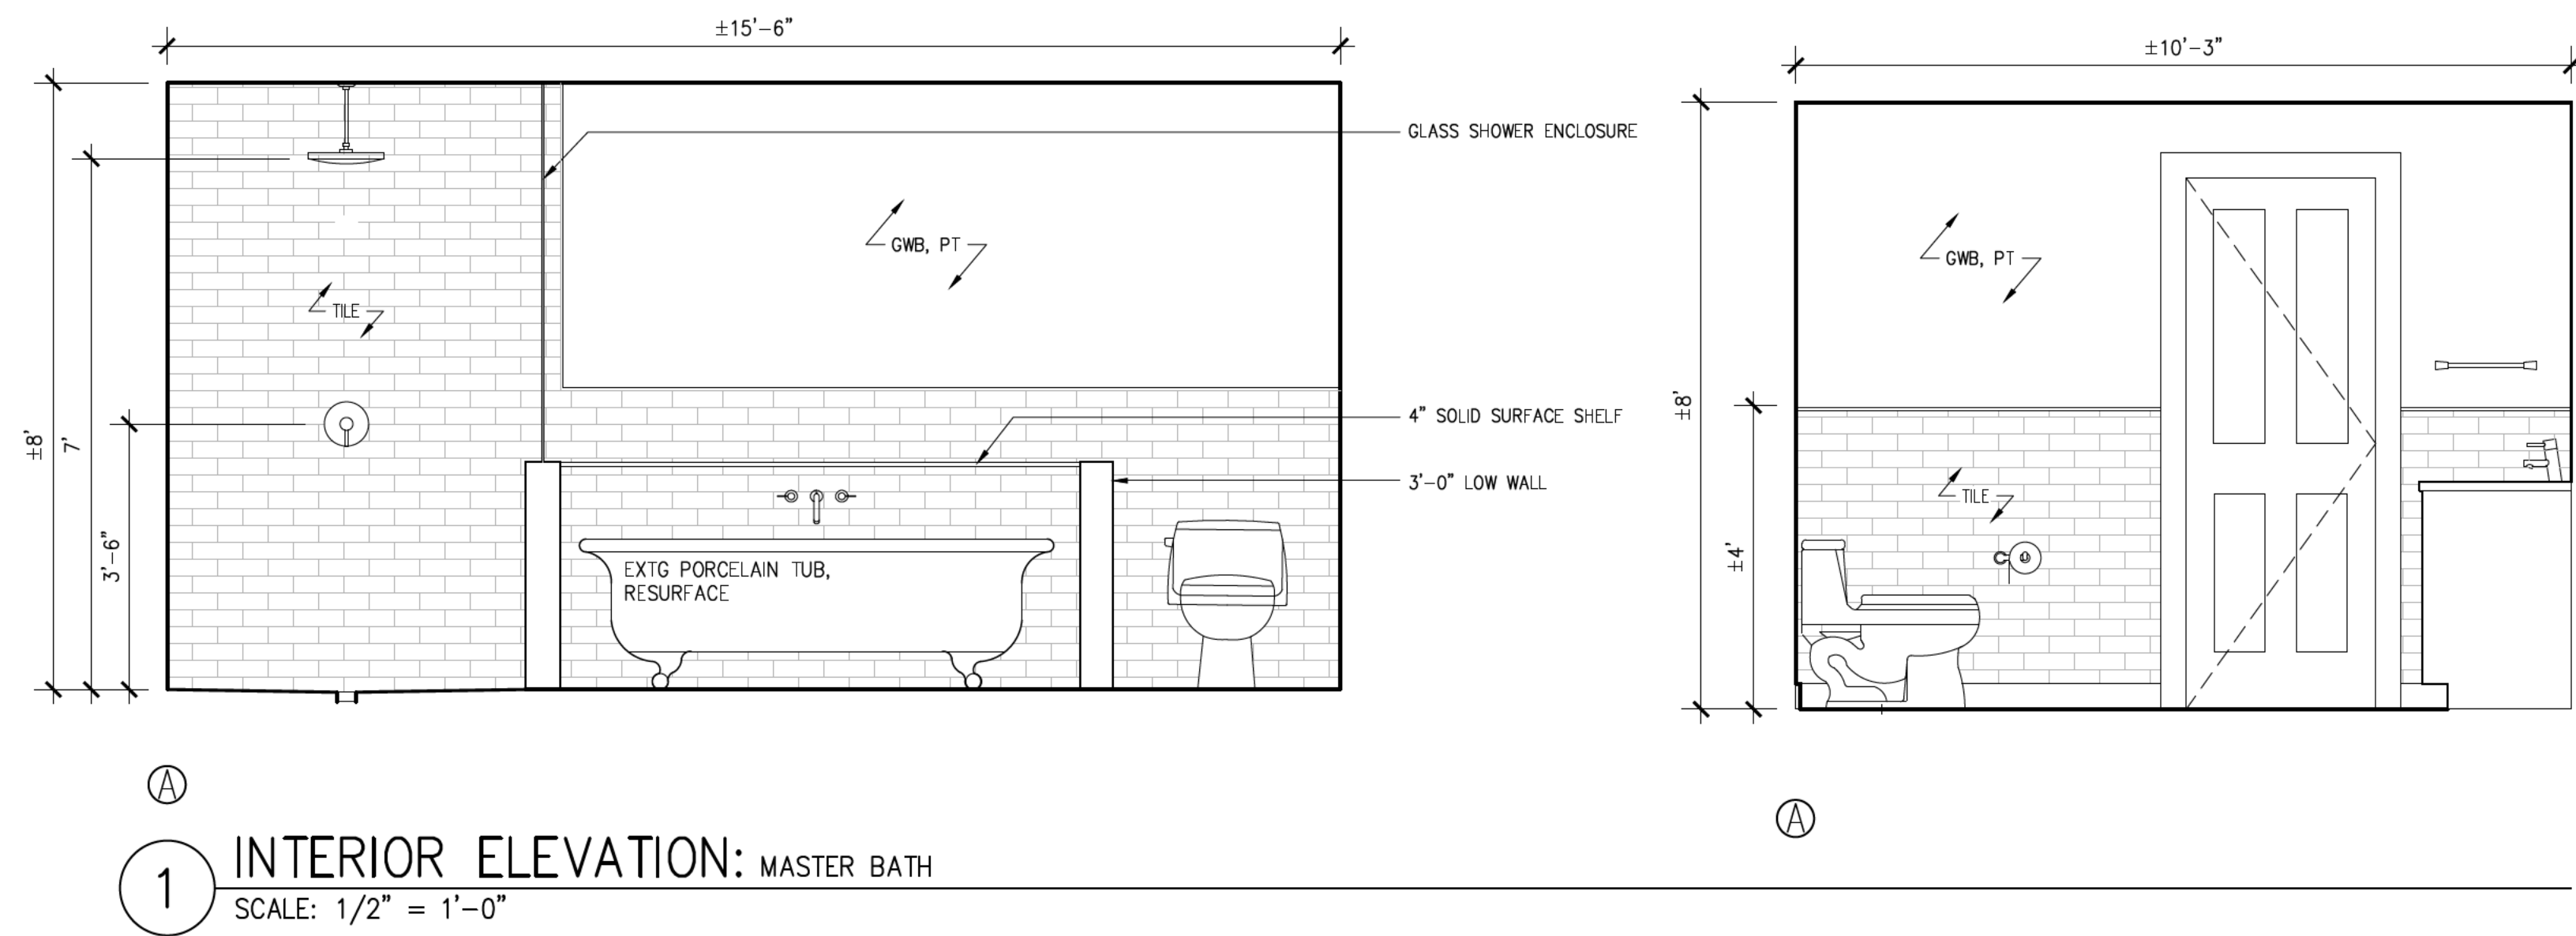


DATE	ISSUED FOR

Tel: 210.883.5529
Fax: 210.920.8249
Email: info@designcooper.com
PO BOX 90946
San Antonio, TX 78209


SAN ANTONIO, TEXAS

DRAWN:DC
CHECKED:BCF
APPROVED:
DATE: OCTOBER 2, 2020
SHEET NO.
INTERIOR ELEVATIONS

A2.2

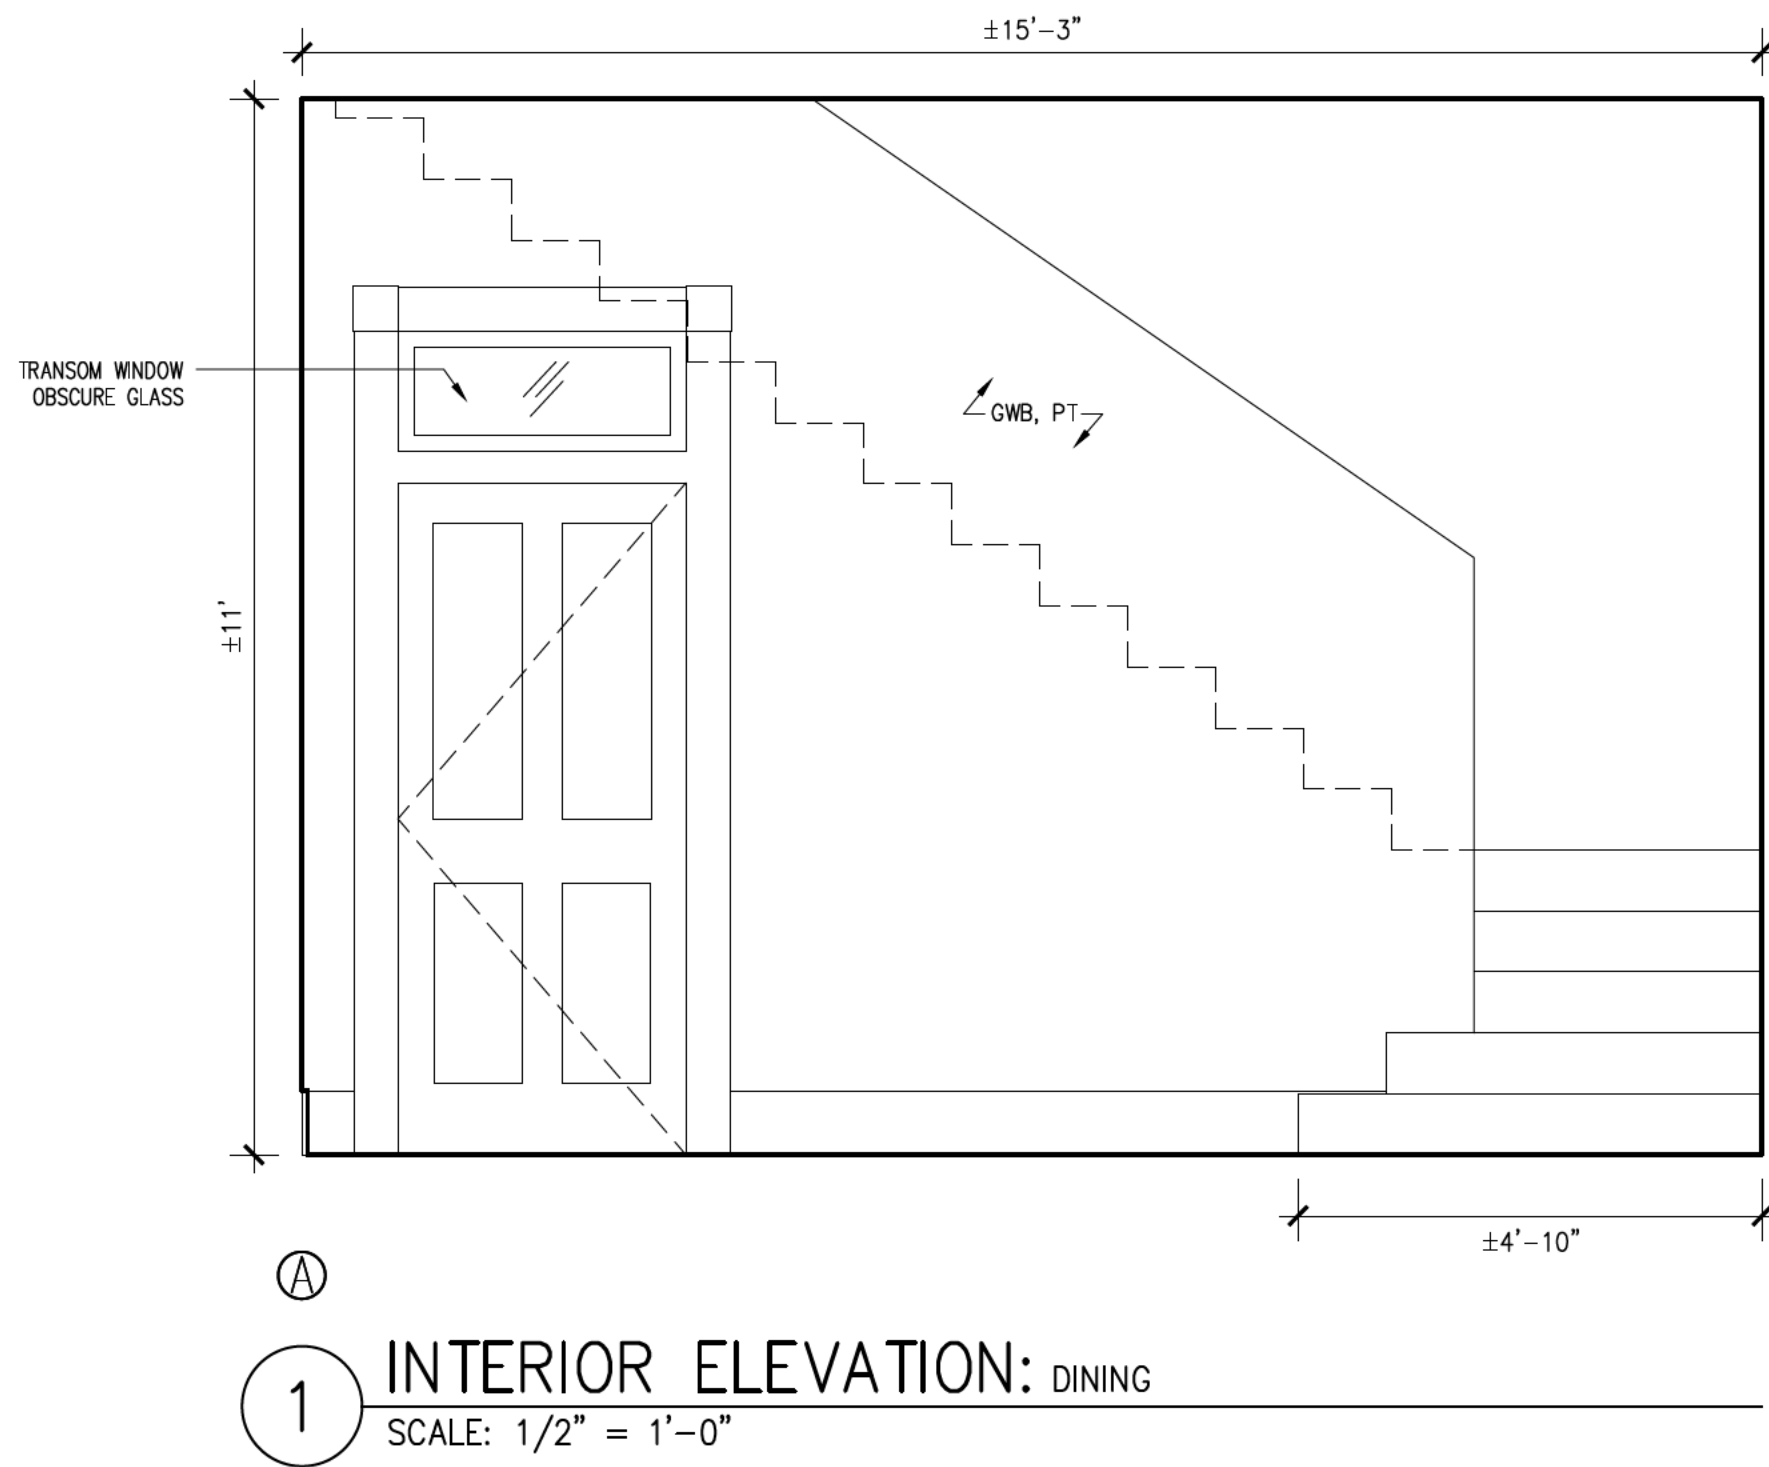


1 INTERIOR ELEVATION: DINING
SCALE: 1/2" = 1'-0"

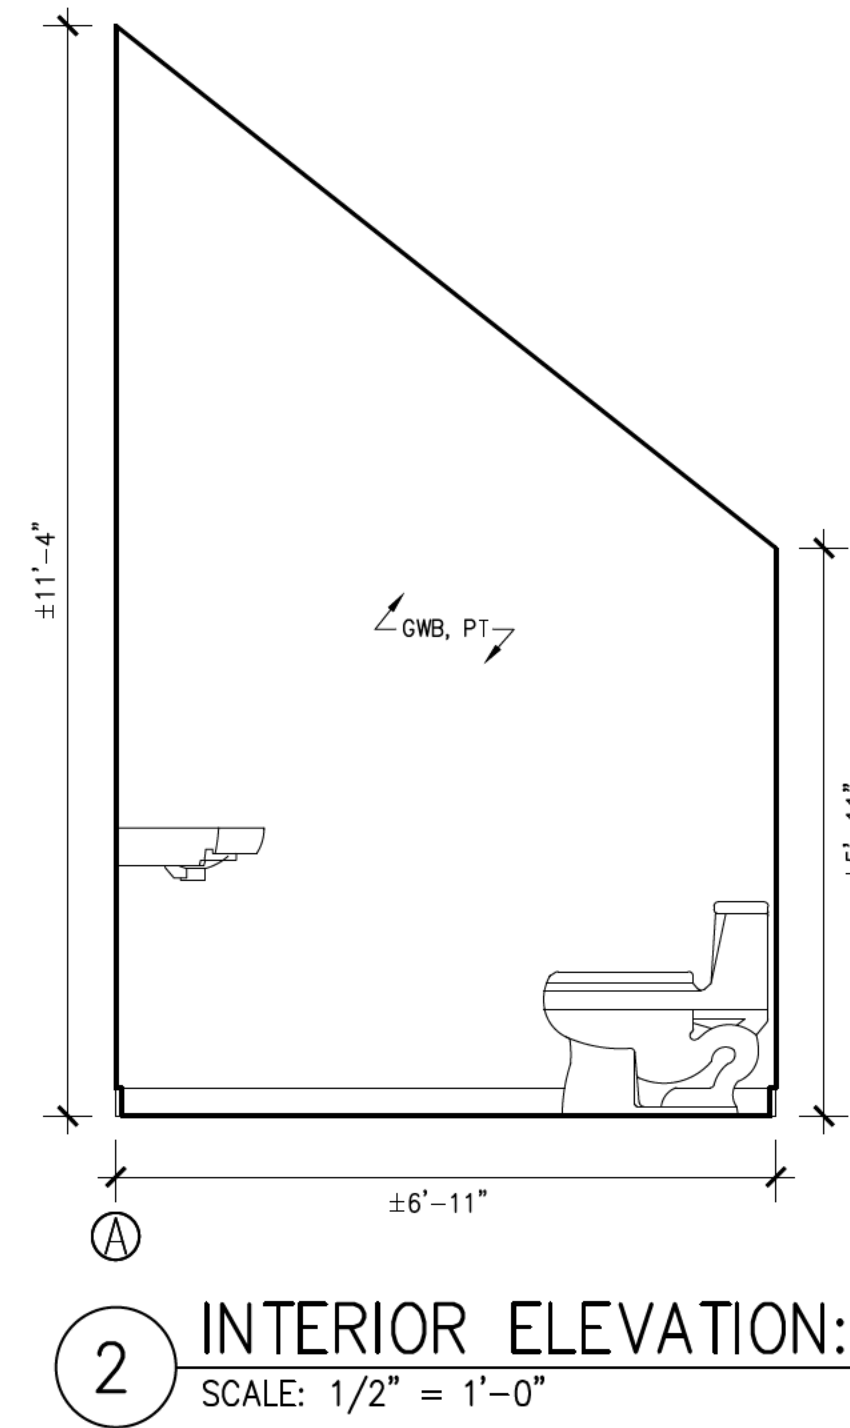

2 INTERIOR ELEVATION: BATH 3
SCALE: 1/2" = 1'-0"

DATE	ISSUED FOR
Tel: 210.883.5599 Fax: 210.820.8209 Email: info@designcooper.com PO BOX 90946 San Antonio, TX 78209	
SAN ANTONIO, TEXAS	
DRAWN:DC	
CHECKED:BCF	
APPROVED:	
DATE: OCTOBER 2, 2020	
SHEET NO. INTERIOR ELEVATIONS	
A2.3	

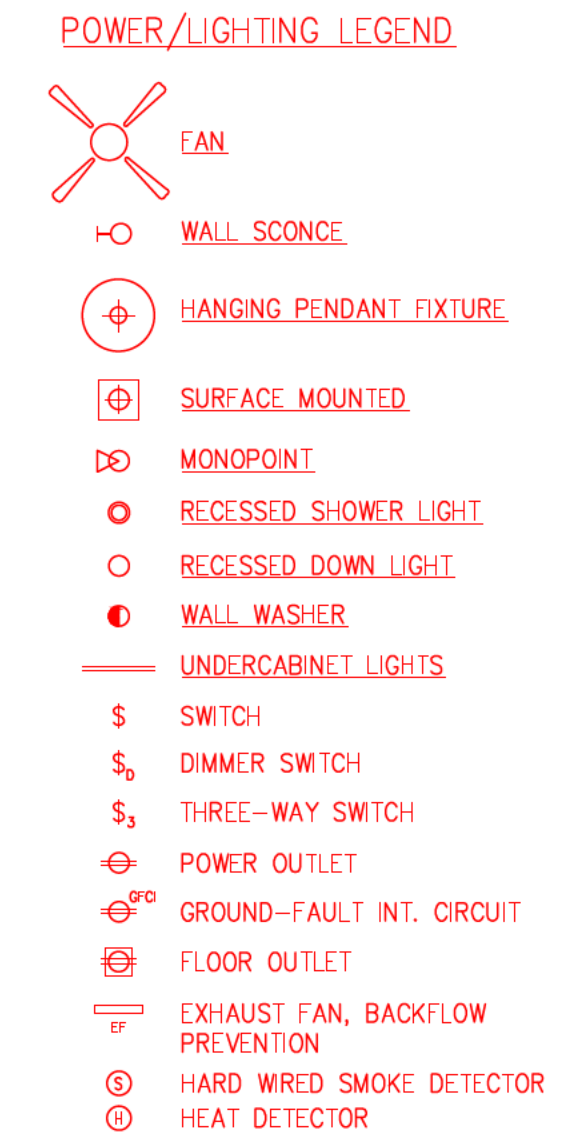

NOTES:

1. DRAWINGS REPRESENT ALL NEW LOCATION FOR RECEPTACLES AND SWITCHES. ELECTRICIAN TO COORDINATE WITH DESIGN COOP ON SITE ABOUT POSSIBLY REUSING EXTG LOCATIONS
2. EXTERIOR LIGHTING IS NOT REPRESENTED ON DRAWINGS, COORDINATE WITH DESIGN COOP ON SITE FOR LOCATIONS OF EXTERIOR LIGHTING

DRAWN:DC
CHECKED:BCF
APPROVED:
DATE: OCTOBER 2, 2020
SHEET NO. ELECTRICAL PLAN

A 4 0